

- NOTE:
- ALL BURIED DIP SHALL BE INSTALLED WITH MECHANICAL JOINT FITTINGS (EBAI MEGA-LUG OR APPROVED EQUAL) AND RESTRAINED JOINT GASKETS (TYTON JOINT OR APPROVED EQUAL).
 - CONTRACTOR TO PROVIDE ADDITIONAL MECHANICAL JOINT FITTINGS AS REQUIRED THAT ARE NOT SHOWN ON THIS DRAWING FOR THE SUCTION AND DISCHARGE PIPING.
 - NEAREST 100-YR FLOOD ELEVATION IS 238'-FT BASED ON FIRM PANEL 0103F - MAP NUMBER 3407320103F - EFFECTIVE DATE OF 06/04/2007.
 - NOTE THERE IS EXISTING RIM UNDER THE DRIVEWAY THAT MAY NEED TO BE REMOVED DURING OF THE ACCESS DRIVE AT THE BOTTOM OF THE HILL NEAR HILLWOOD TERRACE.

PLANT SCHEDULE

TREES	QTY	BOTANICAL NAME	COMMON NAME	CONT	SIZE
THO	9	JUNIPERUS VIRGINIANA	EASTERN RED CEDAR	B&B	8' HEIGHT



REVISIONS	
0	08/25/2023 NJEP RISE PERMIT SUBMISSION
1	04/05/2024 ISSUE FOR BID
2	
3	
4	
5	
6	
7	
8	

**FAIRVIEW AVE WELL FACILITY
PFAS TREATMENT
CIVIL**

SITE GRADING, LAYOUT, UTILITY PLAN


TOWNSHIP OF VERONA, ESSEX COUNTY, NJ
FAIRVIEW AVE WELL FACILITY

JACOBS ENGINEERING GROUP INC.
1000 WASHINGTON AVE.
MORRISTOWN, NJ 07960
NJDC# 246A2790200

DRAWN BY FFB
PROJECT ENGR FFB
APPROVED JH

DATE 10/13/22
PROJECT E6100800
SCALE 1"=20'

C-2 5 OF 34

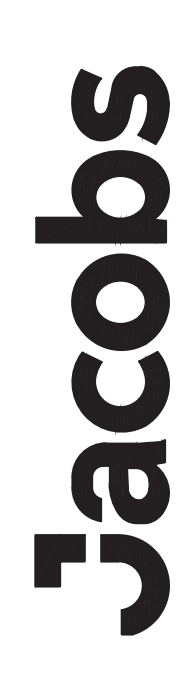

FRANK P BIANK JR., PE
LICENSED PROFESSIONAL ENGINEER
NJPE LICENSE NO. 246E05286900