



DECORATIVE PARK ENTRANCE SIGNAGE

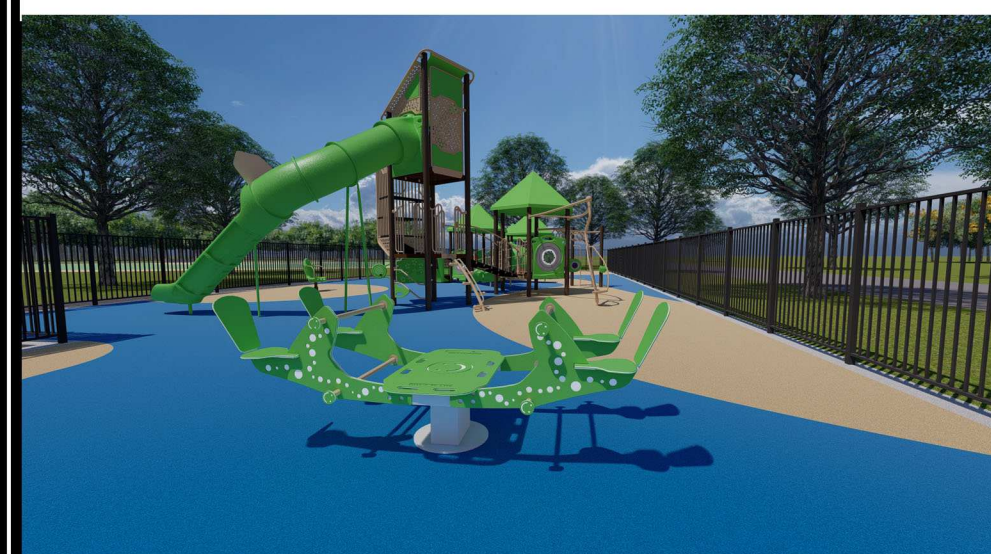

INCLUSIVE JACK'S LAW PLAYGROUND

CAUTION: IF THIS DOCUMENT DOES NOT CONTAIN THE RAISED IMPRESSION SEAL OF THE PROFESSIONAL, IT IS NOT AN AUTHORIZED ORIGINAL DOCUMENT AND MAY HAVE BEEN ALTERED. © COPYRIGHT 2024 BY NEGLIA GROUP. ALL RIGHTS RESERVED.

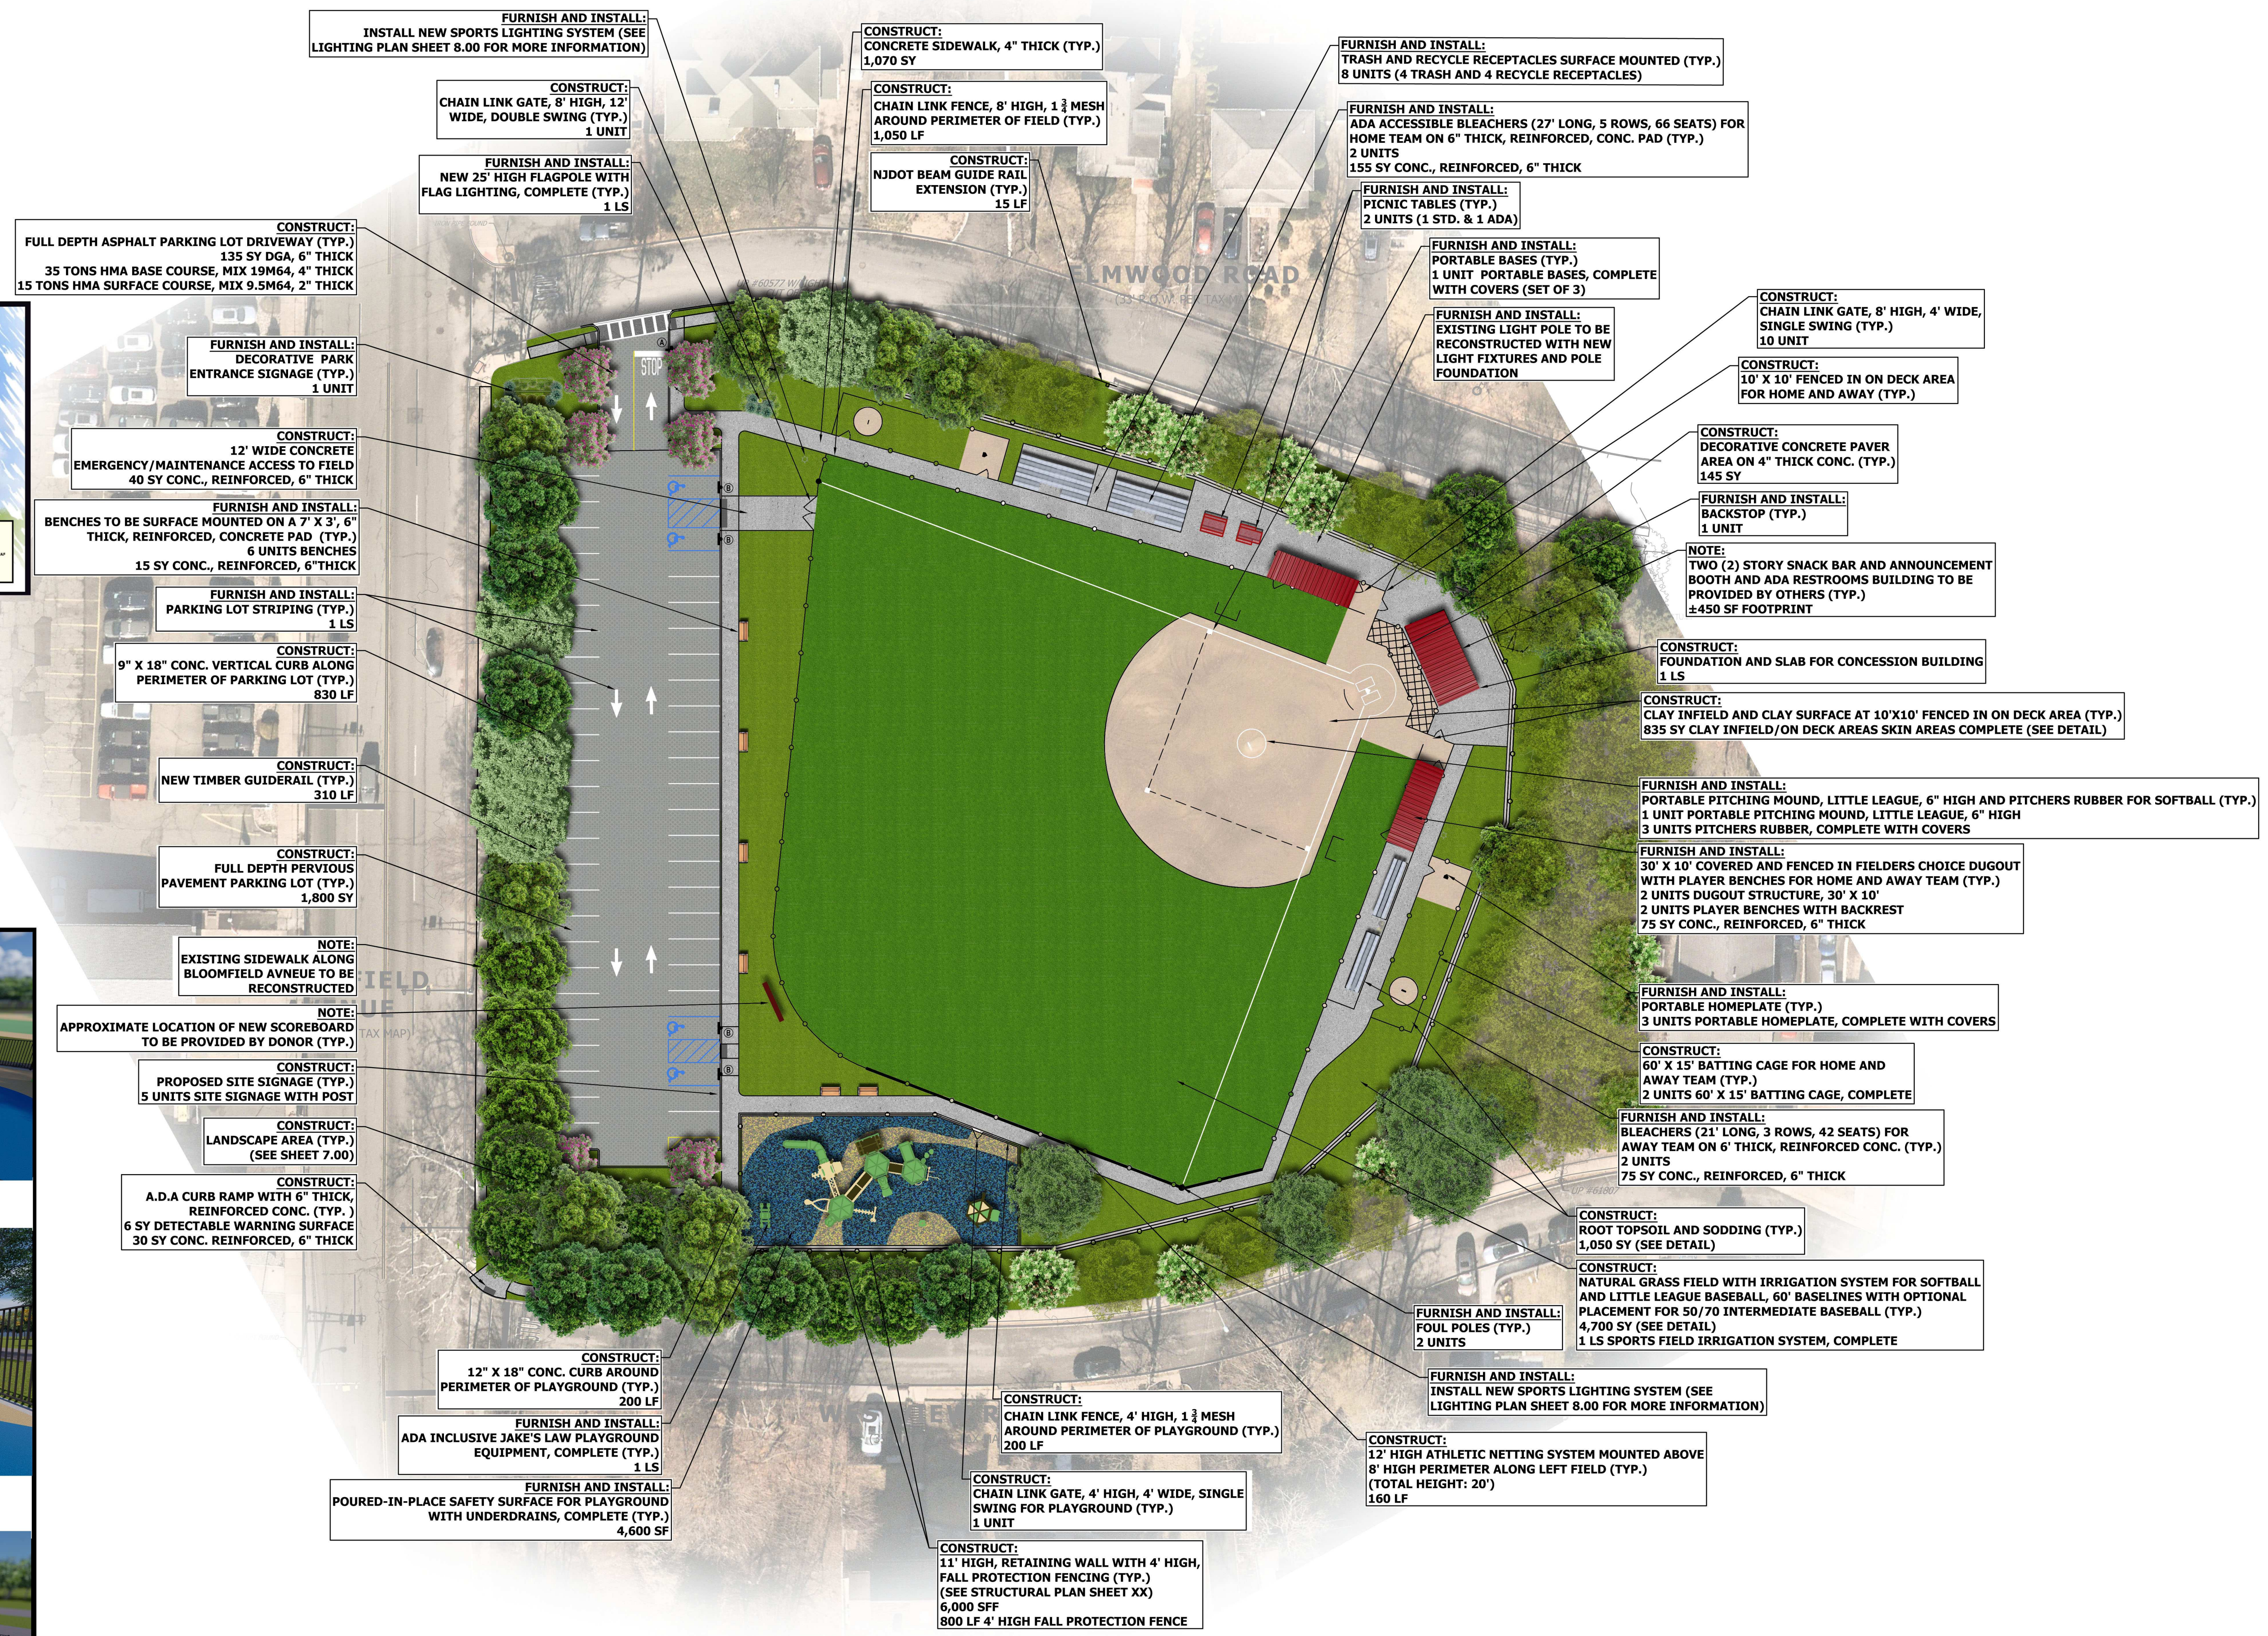

FURNISH AND INSTALL:
INSTALL NEW SPORTS LIGHTING SYSTEM (SEE LIGHTING PLAN SHEET 8.00 FOR MORE INFORMATION)

CONSTRUCT:
CHAIN LINK GATE, 8' HIGH, 12' WIDE, DOUBLE SWING (TYP.)
1 UNIT

FURNISH AND INSTALL:
NEW 25' HIGH FLAGPOLE WITH FLAG LIGHTING, COMPLETE (TYP.)
1 LS

CONSTRUCT:
FULL DEPTH ASPHALT PARKING LOT DRIVEWAY (TYP.)
135 SY DGA, 6" THICK
35 TONS HMA BASE COURSE, MIX 19M64, 4" THICK
15 TONS HMA SURFACE COURSE, MIX 9.5M64, 2" THICK

FURNISH AND INSTALL:
DECORATIVE PARK ENTRANCE SIGNAGE (TYP.)
1 UNIT

CONSTRUCT:
12' WIDE CONCRETE EMERGENCY/MAINTENANCE ACCESS TO FIELD
40 SY CONC., REINFORCED, 6" THICK

FURNISH AND INSTALL:
BENCHES TO BE SURFACE MOUNTED ON A 7' X 3', 6" THICK, REINFORCED, CONCRETE PAD (TYP.)
6 UNITS BENCHES
15 SY CONC., REINFORCED, 6" THICK

FURNISH AND INSTALL:
PARKING LOT STRIPING (TYP.)
1 LS

CONSTRUCT:
9" X 18" CONC. VERTICAL CURB ALONG PERIMETER OF PARKING LOT (TYP.)
830 LF

CONSTRUCT:
NEW TIMBER GUIDERAIL (TYP.)
310 LF

CONSTRUCT:
FULL DEPTH PERVIOUS PAVEMENT PARKING LOT (TYP.)
1,800 SY

NOTE:
EXISTING SIDEWALK ALONG BLOOMFIELD AVENUE TO BE RECONSTRUCTED

NOTE:
APPROXIMATE LOCATION OF NEW SCOREBOARD TO BE PROVIDED BY DONOR (TYP.)

CONSTRUCT:
PROPOSED SITE SIGNAGE (TYP.)
5 UNITS SITE SIGNAGE WITH POST

CONSTRUCT:
LANDSCAPE AREA (TYP.)
(SEE SHEET 7.00)

CONSTRUCT:
A.D.A CURB RAMP WITH 6" THICK, REINFORCED CONC. (TYP.)
6 SY DETECTABLE WARNING SURFACE
30 SY CONC. REINFORCED, 6" THICK

CONSTRUCT:
12" X 18" CONC. CURB AROUND PERIMETER OF PLAYGROUND (TYP.)
200 LF

FURNISH AND INSTALL:
ADA INCLUSIVE JAKE'S LAW PLAYGROUND EQUIPMENT, COMPLETE (TYP.)
1 LS

FURNISH AND INSTALL:
POURED-IN-PLACE SAFETY SURFACE FOR PLAYGROUND WITH UNDERDRAINS, COMPLETE (TYP.)
4,600 SF

CONSTRUCT:
CONCRETE SIDEWALK, 4" THICK (TYP.)
1,070 SY

CONSTRUCT:
CHAIN LINK FENCE, 8' HIGH, 1 1/2" MESH AROUND PERIMETER OF FIELD (TYP.)
1,050 LF

CONSTRUCT:
NJDOT BEAM GUIDE RAIL EXTENSION (TYP.)
15 LF

FURNISH AND INSTALL:
TRASH AND RECYCLE RECEPTACLES SURFACE MOUNTED (TYP.)
8 UNITS (4 TRASH AND 4 RECYCLE RECEPTACLES)

FURNISH AND INSTALL:
ADA ACCESSIBLE BLEACHERS (27' LONG, 5 ROWS, 66 SEATS) FOR HOME TEAM ON 6" THICK, REINFORCED, CONC. PAD (TYP.)
2 UNITS
155 SY CONC., REINFORCED, 6" THICK

FURNISH AND INSTALL:
PICNIC TABLES (TYP.)
2 UNITS (1 STD. & 1 ADA)

FURNISH AND INSTALL:
PORTABLE BASES (TYP.)
1 UNIT PORTABLE BASES, COMPLETE WITH COVERS (SET OF 3)

FURNISH AND INSTALL:
EXISTING LIGHT POLE TO BE RECONSTRUCTED WITH NEW LIGHT FIXTURES AND POLE FOUNDATION

CONSTRUCT:
CHAIN LINK GATE, 8' HIGH, 4' WIDE, SINGLE SWING (TYP.)
10 UNIT

CONSTRUCT:
10' X 10' FENCED IN ON DECK AREA FOR HOME AND AWAY (TYP.)

CONSTRUCT:
DECORATIVE CONCRETE PAVER AREA ON 4" THICK CONC. (TYP.)
145 SY

FURNISH AND INSTALL:
BACKSTOP (TYP.)
1 UNIT

NOTE:
TWO (2) STORY SNACK BAR AND ANNOUNCEMENT BOOTH AND ADA RESTROOMS BUILDING TO BE PROVIDED BY OTHERS (TYP.)
±450 SF FOOTPRINT

CONSTRUCT:
FOUNDATION AND SLAB FOR CONCESSION BUILDING
1 LS

CONSTRUCT:
CLAY INFIELD AND CLAY SURFACE AT 10'X10' FENCED IN ON DECK AREA (TYP.)
835 SY CLAY INFIELD/ON DECK AREAS SKIN AREAS COMPLETE (SEE DETAIL)

FURNISH AND INSTALL:
PORTABLE PITCHING MOUND, LITTLE LEAGUE, 6" HIGH AND PITCHERS RUBBER FOR SOFTBALL (TYP.)
1 UNIT PORTABLE PITCHING MOUND, LITTLE LEAGUE, 6" HIGH
3 UNITS PITCHERS RUBBER, COMPLETE WITH COVERS

FURNISH AND INSTALL:
30' X 10' COVERED AND FENCED IN FIELDERS CHOICE DUGOUT WITH PLAYER BENCHES FOR HOME AND AWAY TEAM (TYP.)
2 UNITS DUGOUT STRUCTURE, 30' X 10'
2 UNITS PLAYER BENCHES WITH BACKREST
75 SY CONC., REINFORCED, 6" THICK

FURNISH AND INSTALL:
PORTABLE HOMEPLATE (TYP.)
3 UNITS PORTABLE HOMEPLATE, COMPLETE WITH COVERS

CONSTRUCT:
60' X 15' BATTING CAGE FOR HOME AND AWAY TEAM (TYP.)
2 UNITS 60' X 15' BATTING CAGE, COMPLETE

FURNISH AND INSTALL:
BLEACHERS (21' LONG, 3 ROWS, 42 SEATS) FOR AWAY TEAM ON 6" THICK, REINFORCED CONC. (TYP.)
2 UNITS
75 SY CONC., REINFORCED, 6" THICK

CONSTRUCT:
ROOT TOPSOIL AND SODDING (TYP.)
1,050 SY (SEE DETAIL)

CONSTRUCT:
NATURAL GRASS FIELD WITH IRRIGATION SYSTEM FOR SOFTBALL AND LITTLE LEAGUE BASEBALL, 60' BASELINES WITH OPTIONAL PLACEMENT FOR 50/70 INTERMEDIATE BASEBALL (TYP.)
4,700 SY (SEE DETAIL)
1 LS SPORTS FIELD IRRIGATION SYSTEM, COMPLETE

FURNISH AND INSTALL:
FOUL POLES (TYP.)
2 UNITS

FURNISH AND INSTALL:
INSTALL NEW SPORTS LIGHTING SYSTEM (SEE LIGHTING PLAN SHEET 8.00 FOR MORE INFORMATION)

CONSTRUCT:
12' HIGH ATHLETIC NETTING SYSTEM MOUNTED ABOVE 8' HIGH PERIMETER ALONG LEFT FIELD (TYP.)
(TOTAL HEIGHT: 20')
160 LF

CONSTRUCT:
CHAIN LINK FENCE, 4' HIGH, 1 1/2" MESH AROUND PERIMETER OF PLAYGROUND (TYP.)
200 LF

CONSTRUCT:
CHAIN LINK GATE, 4' HIGH, 4' WIDE, SINGLE SWING FOR PLAYGROUND (TYP.)
1 UNIT

CONSTRUCT:
11' HIGH, RETAINING WALL WITH 4' HIGH, FALL PROTECTION FENCING (TYP.)
(SEE STRUCTURAL PLAN SHEET XX)
6,000 SF
800 LF 4' HIGH FALL PROTECTION FENCE

NEGLIA GROUP
EXPERIENCED DEDICATED RESPONSIVE

LYNDHURST
34 PARK AVENUE, PO BOX 465
LYNDHURST
NEW JERSEY 07071
PHONE: 201.939.8805
FAX: 201.939.0846
INFO@NEGLIAGROUP.COM

MOUNTAINSIDE
200 CENTRAL AVENUE, SUITE 102
MOUNTAINSIDE
NEW JERSEY 07092
PHONE: 201.939.8805
FAX: 732.943.7249
NEGLIAGROUP.COM

NO.	DATE	REVISION

FINAL



EVERETT PARK IMPROVEMENTS

BLOCK 707 - LOT 10
TOWNSHIP OF VERONA
COUNTY OF ESSEX
STATE OF NEW JERSEY

ANTHONY KURUS, PE, PP
PROFESSIONAL ENGINEER
N.J. LICENSE NO. 24626944800

(Signature)

MATEO F. LUZURIAGA, PE
PROFESSIONAL ENGINEER
N.J. LICENSE NO. 24626902800

SITE PLAN

DRAWN BY:	M.F.L.	SCALE:	1" = 30'
DESIGNED BY:	M.F.L.	CHECKED BY:	A.K.
PROJECT NO.:	VEROMUN24.010	3.00	
DATE:	NOVEMBER 2024		

CERTIFICATE OF AUTHORIZATION (N.J.S.A. 45:8-56) 24GA2792700